
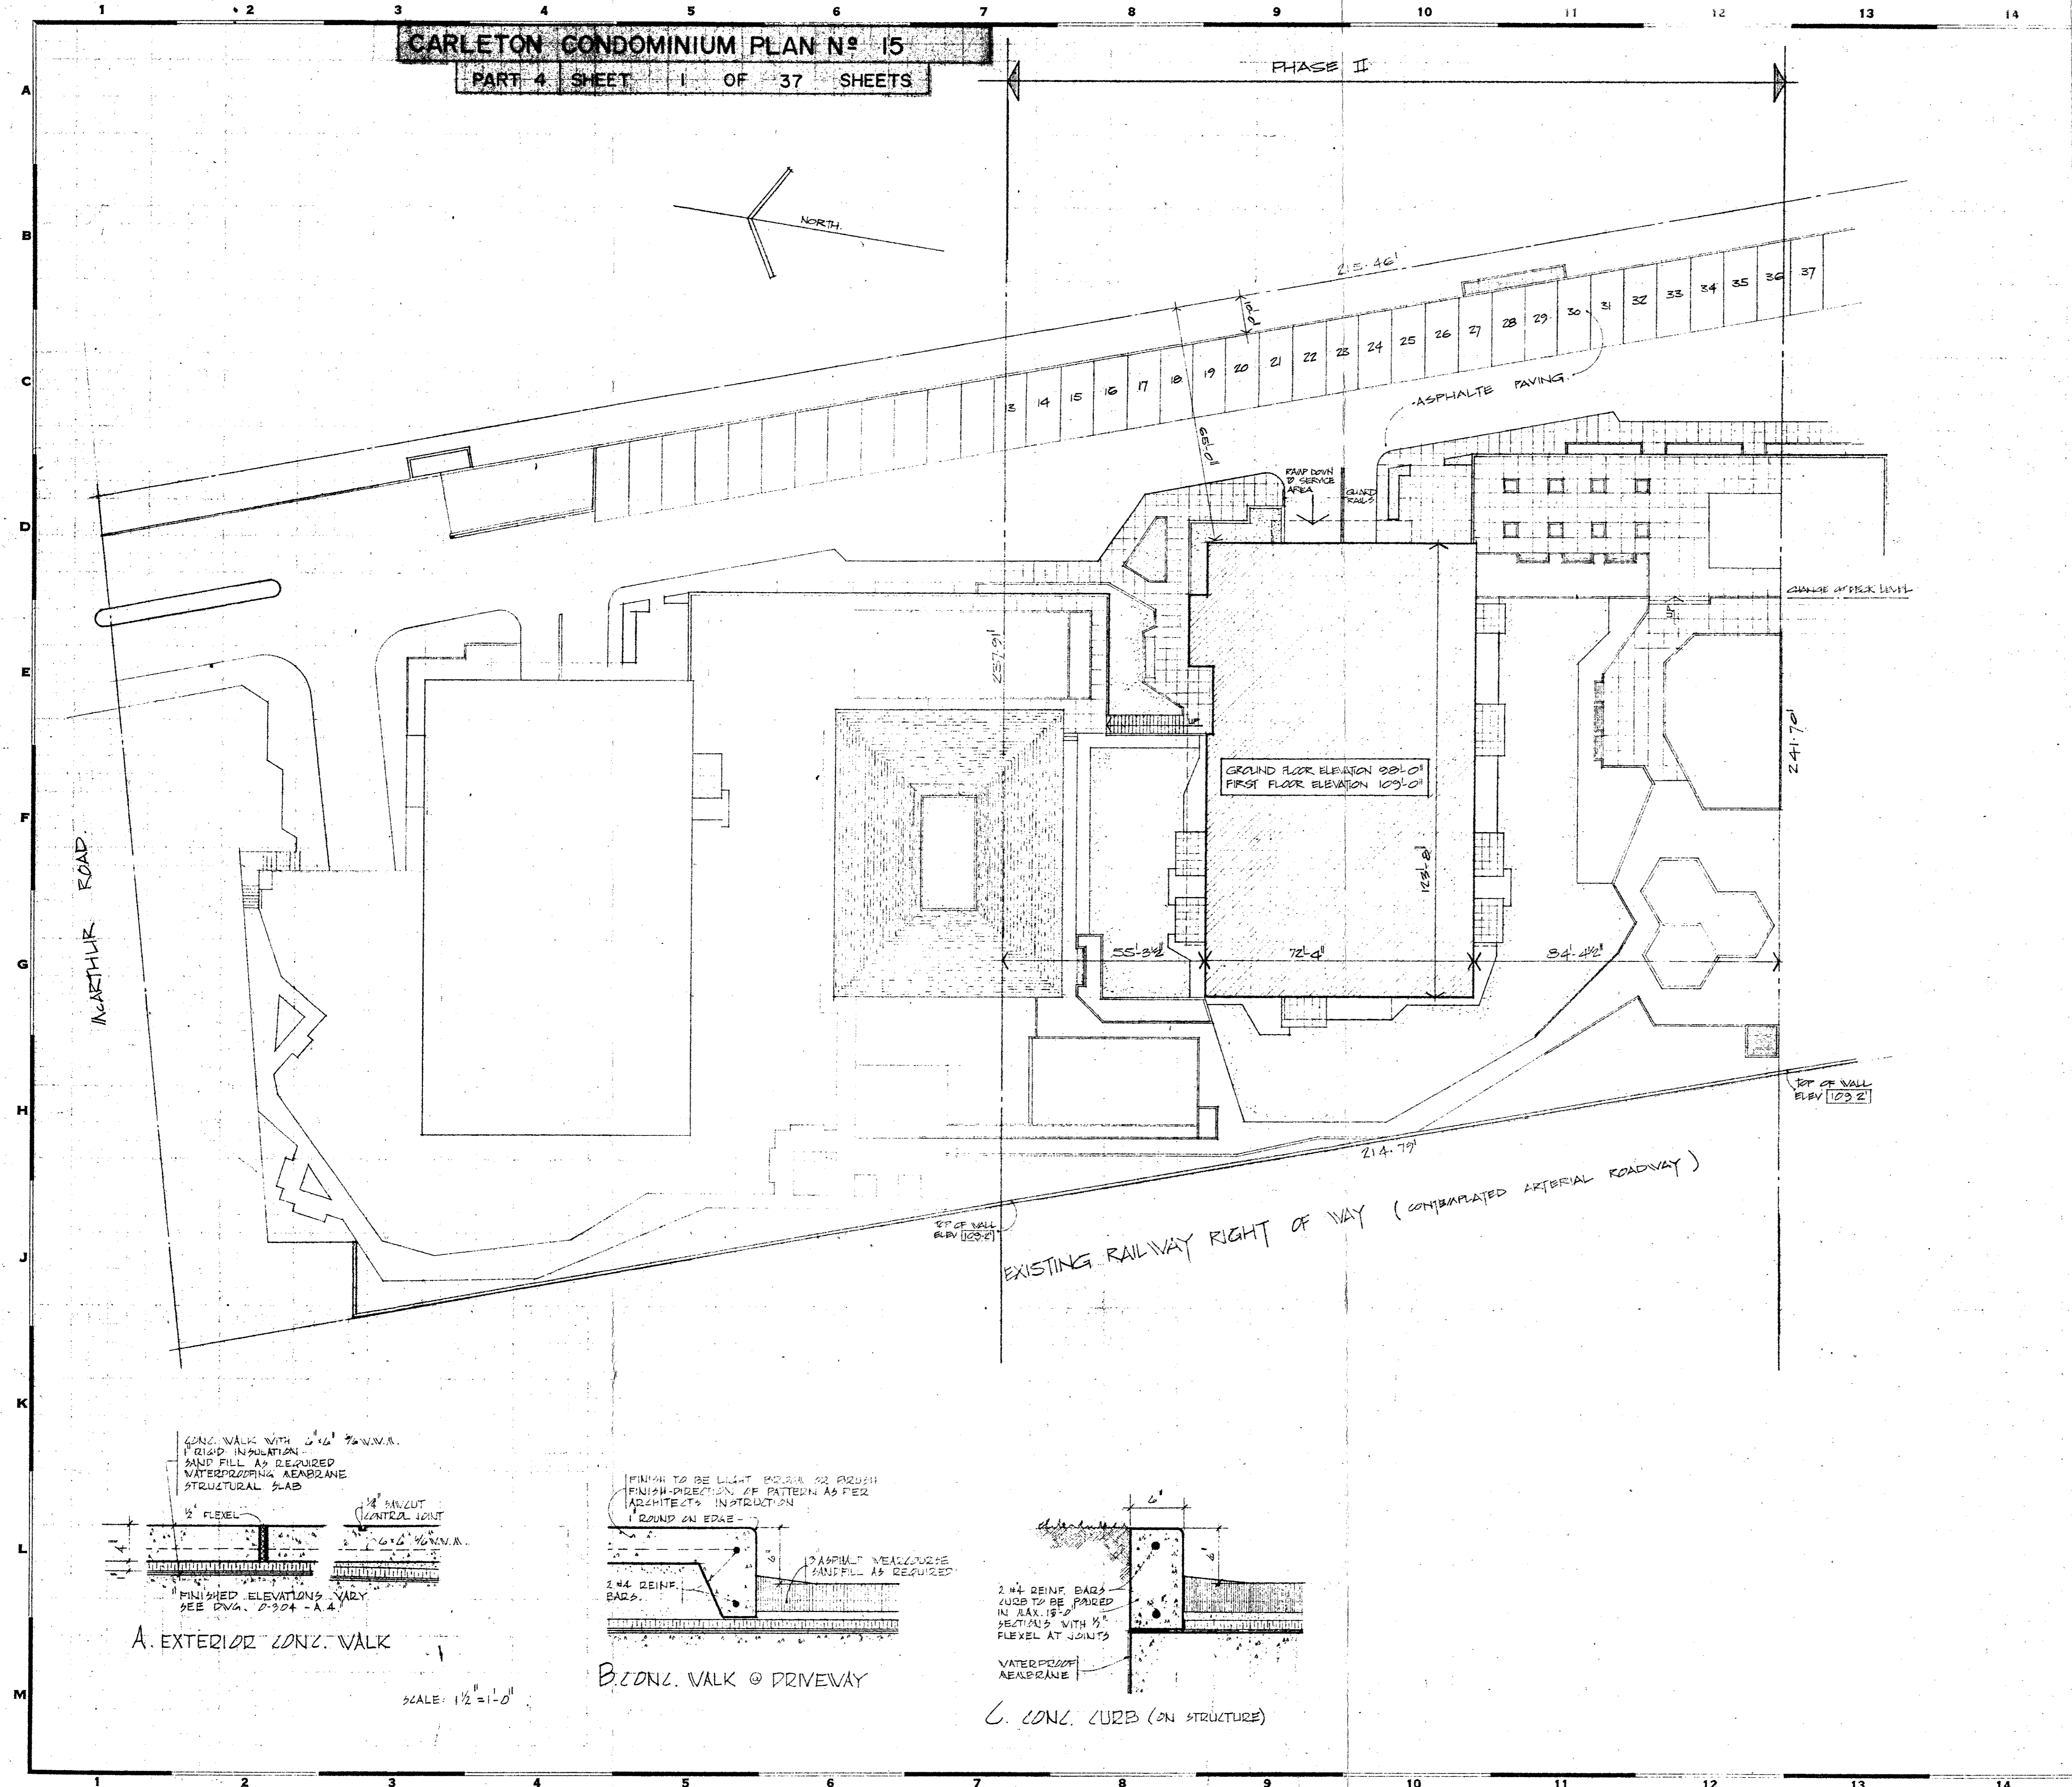


CARLETON CONDOMINIUM PLAN N° 15

PART 4 SHEET 1 OF 37 SHEETS

PHASE II

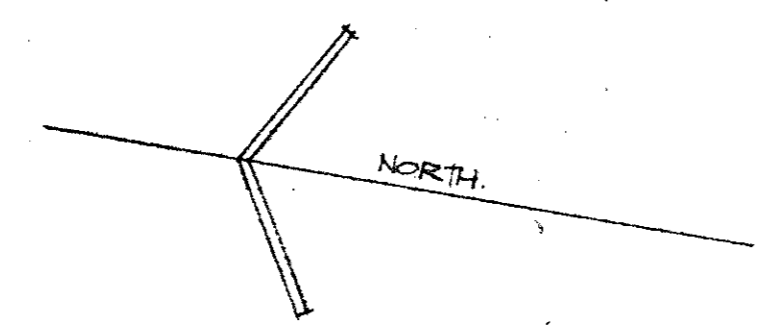

LIST OF DRAWINGS


NO.	TITLE
ARCHITECTURAL	
A-1	SITE PLAN + LIST OF DRAWINGS
A-2	BASEMENT FLOOR PLAN
A-3	BASEMENT FLOOR PLAN
A-4	GROUND FLOOR PLAN
A-5	GROUND FLOOR PLAN
A-6	1ST FLOOR PLAN
A-7	1ST FLOOR PLAN
A-8	PENTHOUSE FLOOR PLAN
A-9	PENTHOUSE FLOOR PLAN
A-10	MECHANICAL & ELEVATION MAINTENANCE PLAN, CARETAKERS APARTMENT
A-11	NORTH & WEST ELEVATIONS
A-12	SOUTH & EAST ELEVATIONS
A-13	SECTION A-A
A-14	SECTION B-B
A-15	SECTIONS C-C D-D E-E
A-16	APARTMENT BUILDING SECTIONS & DETAILS
A-17	ENCLOSURE SECTION SECTIONS & DETAILS
A-18	SWIMMING POOL ENCLOSURE & DETAILS
A-19	SWIMMING POOL ELEVATIONS
A-20	PART NORTH & SOUTH ELEVATIONS
A-21	PART EAST & WEST ELEVATIONS
A-22	FINISH SCHEDULE
A-23	FINISH SCHEDULE
STRUCTURAL	
S-1	FOUNDATION PLAN
S-2	GROUND FLOOR PLAN - WEST
S-3	GROUND FLOOR PLAN - EAST
S-4	1ST FLOOR PLAN - WEST
S-5	1ST FLOOR PLAN - EAST
S-6	TYPICAL FLOOR & PENTHOUSE FLOOR PLAN
S-7	ROOF PLAN
S-8	COLUMN SCHEDULE
S-9	SHEAR WALLS
S-10	SHEAR WALLS
S-11	SHEAR WALLS
S-12	DETAILS
S-13	BEAM SCHEDULE & DETAILS
S-14	SWIMMING POOL ROOF DETAILS
S-15	DETAILS
MECHANICAL	
M-1	LOWER PARKING EAST
M-2	LOWER PARKING WEST
M-3	UPPER PARKING LEVEL GROUND FLOOR
M-4	UPPER PARKING LEVEL GROUND FLOOR
M-5	FIRST FLOOR PLAN
M-6	TYPICAL FLOOR PLAN - 2ND TO 11TH
M-7	16TH FLOOR PLAN
M-8	PENTHOUSE FLOOR PLAN
M-9	PENTHOUSE EQUIPMENT ROOM PLAN
M-10	RISER DIAGRAMS
M-11	POOL
M-12	PARTY ROOM
ELECTRICAL	
E-1	SITE PLAN LEGEND
E-2	TRANSFORMER VAULT
E-3	MAIN POWER RISER & FIRE ALARM
E-4	RISER DIAGRAM
E-5	LOWER PARKING LEVEL - WEST
E-6	LOWER PARKING LEVEL - EAST
E-7	UPPER PARKING LEVEL / GROUND FLOOR
E-8	UPPER PARKING LEVEL / SCHEDULES
E-9	PHASE I RENOVATIONS
E-10	TYPICAL FLOOR PLAN
E-11	PENTHOUSE PLAN
E-12	PENTHOUSE EQUIPMENT ROOM PLAN
E-13	LIGHTNING PROTECTION & DETAILS
E-14	SWIMMING POOL
LANDSCAPING	
L-1	TO L-5

NOTES


1. **NOTES** NEW FINISHED GRADE LEVELS
EXISTING GRADE LEVELS
2. SETTING OUT DIMENSIONS ARE TAKEN TO THE BUILDING FACE
3. SITE INFORMATION TAKEN FROM DRAWING PREPARED BY FAIRHALL & MOFFATT - ONTARIO LAND SURVEYORS, OTTAWA ONTARIO FOR LOT 1 REQ'D PLAN 70, VANIER CITY - FORMERLY CITY OF EASTVIEW DATED AT OTTAWA, FEBRUARY 11TH 1971. REFERENCE DRAWING NO. 3700 GR - IN CASE OF DISCREPANCY THE SURVEYORS PLAN WILL GOVERN
4. FOR ALL FINISHED LANDSCAPING DETAILS SEE LANDSCAPE ARCHITECT'S DRAWINGS
5. PROVIDE CONTINUOUS, WATERPROOF, EXPANSION JOINT AT ALL LEVELS WHICH COME IN CONTACT WITH EXISTING SURFACES.

RECEIVED
DEC-8 1972


DIRECTOR OF LEGAL SURVEYS

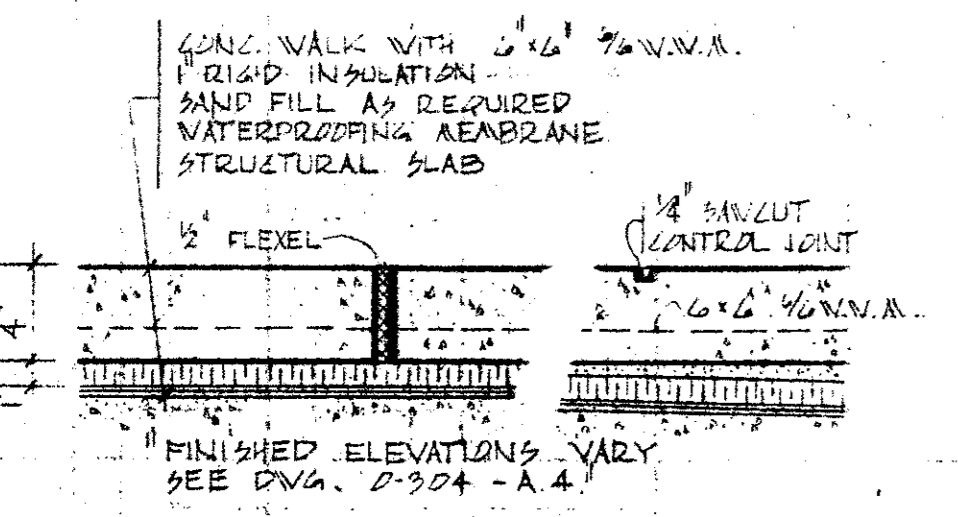

A. EXTERIOR CONZ. WALK

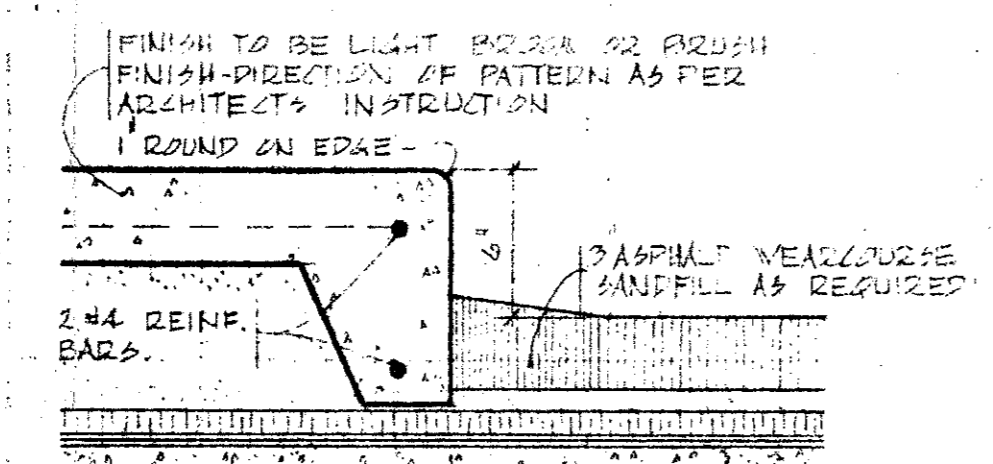

B. CONZ. WALK @ DRIVEWAY

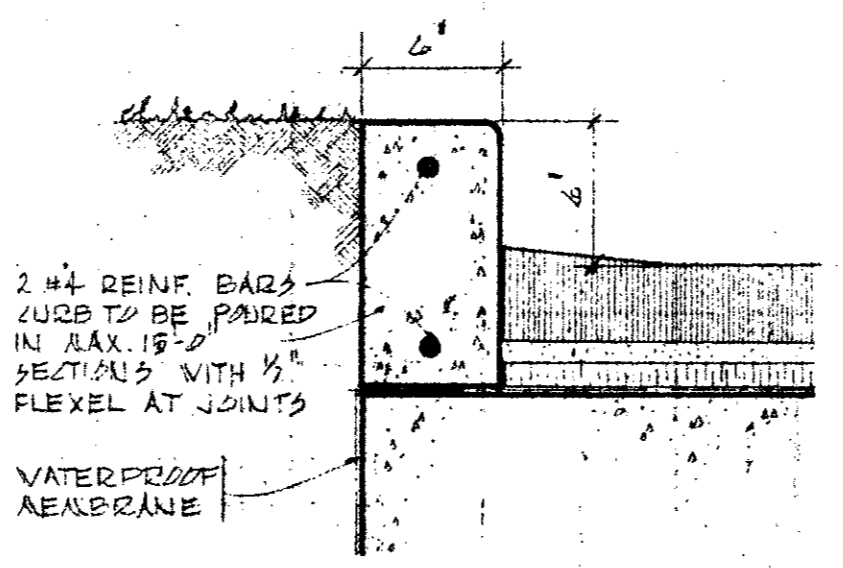

C. CONZ. CURB (ON STRUCTURE)

SCALE: 1/2" = 1'-0"

CRAIG AND KOHLER ARCHITECTS
OTTAWA, ONTARIO

100 UNIT CARLETON
CHATEAU VANER CENTRE (PHASE II)
VANIER CITY
OTTAWA, ONTARIO

SITE PLAN + LIST OF DWGS.

DESIGNED BY: P.A./E. J.S.C. SCALE: 1/2" = 1'-0" DATE: 10/24/71 DRAWING NO: 0-301A

CONTRACTOR TO CHECK AND VERIFY ALL DIMENSIONS ON THE JOB

CRAIG AND KOHLER ARCHITECTS